



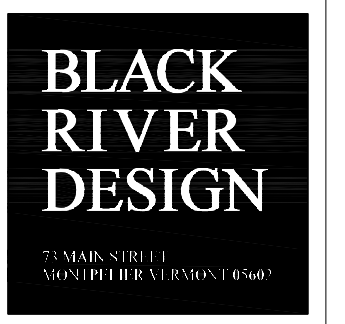

1 ROOF LAYOUT
1/4" = 1'-0"

BRUEGGER'S AT WESTVILLE
WHALLEY AVE.
NEW HAVEN, CONNECTICUT

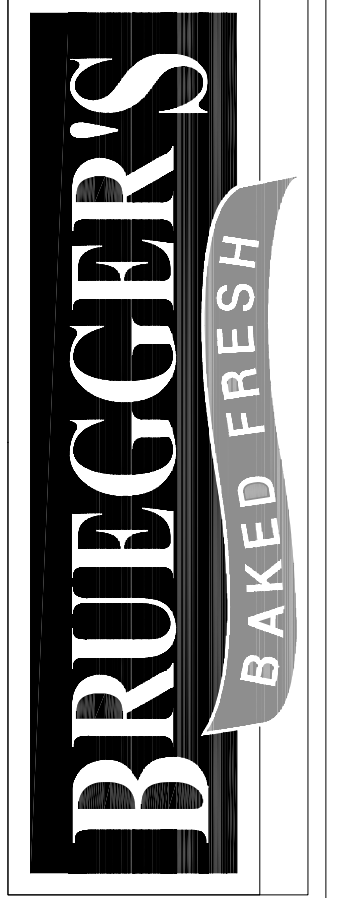

PLUMBING
ROOF PLAN
SCALE
AS NOTED
DATE
MAY 26, 2009
DRAWN BY
GRC
CHECKED BY
TPR

P4